


ALL RIGHTS RESERVED. NO PORTION OF THIS PUBLICATION, WHETHER IN WHOLE OR IN PART CAN BE REPRODUCED WITHOUT THE EXPRESS WRITTEN CONSENT OF SPC TECHNOLOGY.

REVISIONS			DDC. NO. SPC-F004 * Effective: 12/21/98 * DCP No: 680					
DCP #	REV	DESCRIPTION	DRAWN	DATE	CHECKD	DATE	APPRVD	DATE
1979	A	RELEASED	JN	10/07/08	JWM	10/07/08	JWM	10/07/08

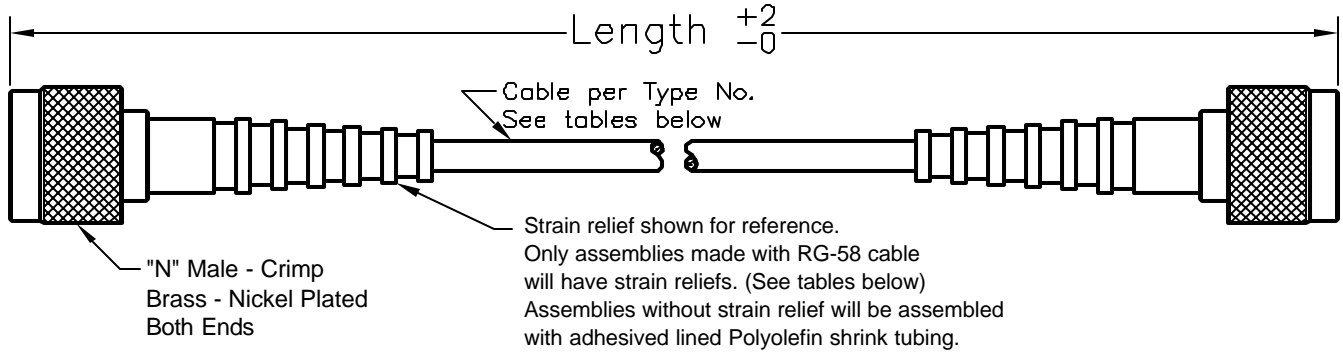

Type No.	Cable	Length <small>(inches)</small>	Strain Relief
SPC20585	RG-8A/U	24	No
SPC20586	RG-8A/U	36	No
SPC20587	RG-8A/U	60	No
SPC20588	RG-8A/U	72	No
SPC20589	RG-55B/U	24	No
SPC20590	RG-55B/U	36	No
SPC20591	RG-55B/U	60	No
SPC20592	RG-58A/U	36	Yes
SPC20593	RG-58A/U	48	Yes
SPC20594	RG-58A/U	60	Yes
SPC20595	RG-58C/U	60	Yes
SPC20837	RG-142B/U	60	No
SPC20838	RG-188A/U	12	No
SPC20839	RG-188A/U	24	No
SPC20840	RG-213/U	60	No

SPC-F004.DWG

**DISCLAIMER:**  
ALL STATEMENTS AND TECHNICAL INFORMATION CONTAINED HEREIN ARE BASED UPON INFORMATION AND/OR TESTS WE BELIEVE TO BE ACCURATE AND RELIABLE. SINCE CONDITIONS OF USE ARE BEYOND OUR CONTROL, THE USER SHALL DETERMINE THE SUITABILITY OF THE PRODUCT FOR THE INTENDED USE AND ASSUME ALL RISK AND LIABILITY WHATSOEVER IN CONNECTION THEREWITH.



**SPC TECHNOLOGY**

UNLESS OTHERWISE SPECIFIED, DIMENSIONS ARE FOR REFERENCE PURPOSES ONLY.

DRAWN BY:	DATE:
Jason Nash	10/07/08
CHECKED BY:	DATE:
JWM	10/07/08
APPROVED BY:	DATE:
JWM	10/07/08

DRAWING TITLE:  
**Cable Assembly – N Male to N Male**

SIZE	DWG. NO.	ELECTRONIC FILE	REV
A	TA-947	TA-947.dwg	A
SCALE: NTS	U.O.M.: INCHES [mm]	SHEET: 1 OF 1	