


ALL RIGHTS RESERVED. NO PORTION OF THIS PUBLICATION, WHETHER IN WHOLE OR IN PART CAN BE REPRODUCED WITHOUT THE EXPRESS WRITTEN CONSENT OF SPC TECHNOLOGY.

REVISIONS			DDC. NO. SPC-F004 * Effective: 12/21/98 * DCP No: 680					
DCP #	REV	DESCRIPTION	DRAWN	DATE	CHECKD	DATE	APPRVD	DATE
1979	A	RELEASED	JWM	2/14/00	JN	03/17/08	JN	03/17/08

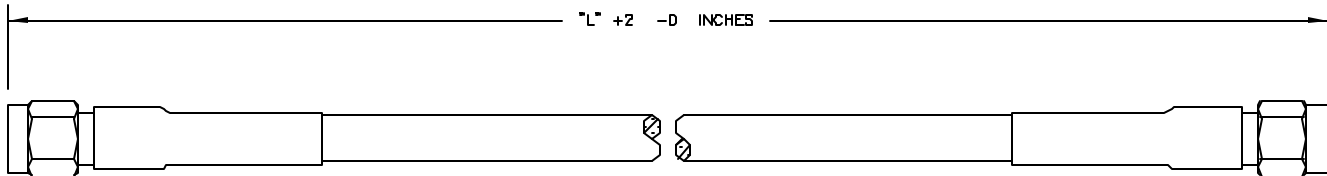

RFW-5000-XX  
 [L] LENGTH IN INCHES  
 SPECIFIC PART NUMBER  
 CABLE ASSEMBLY DESIGNATOR

SPC #	Cable Type	Length	Strain Relief
SPC20619	RG-55B/U	12	No
SPC20620	RG-55B/U	24	No
SPC20621	RG-55B/U	36	No
SPC20622	RG-55B/U	48	No
SPC20623	RG-55B/U	60	No
SPC20626	RG-58A/U	12	Yes
SPC20627	RG-58A/U	24	Yes
SPC20628	RG-58A/U	36	Yes
SPC20629	RG-58A/U	60	Yes
SPC20630	RG-58A/U	72	Yes
SPC20631	RG-58C/U	12	No
SPC20632	RG-58C/U	24	No
SPC20633	RG-58C/U	36	No
SPC20634	RG-58C/U	60	No
SPC20635	RG-58C/U	72	No



SPC-F004.DWG

**DISCLAIMER:**  
 ALL STATEMENTS AND TECHNICAL INFORMATION CONTAINED HEREIN ARE BASED UPON INFORMATION AND/OR TESTS WE BELIEVE TO BE ACCURATE AND RELIABLE. SINCE CONDITIONS OF USE ARE BEYOND OUR CONTROL, THE USER SHALL DETERMINE THE SUITABILITY OF THE PRODUCT FOR THE INTENDED USE AND ASSUME ALL RISK AND LIABILITY WHATSOEVER IN CONNECTION THEREWITH.



**SPC TECHNOLOGY**

UNLESS OTHERWISE SPECIFIED, DIMENSIONS ARE FOR REFERENCE PURPOSES ONLY.	DRAWN BY:	DATE:	DRAWING TITLE: CABLE ASSEMBLY			
	Jeff McVicker	2/14/00	SIZE	DWG. NO.	ELECTRONIC FILE	REV
	CHECKED BY:	DATE:	A	TA-836	TA-836.DWG	A
	Jason Nash	03/17/08	SCALE: NTS	U.O.M.: INCHES [mm]	SHEET: 1 OF 1	
	APPROVED BY:	DATE:				
	Jason Nash	03/17/08				