


ALL RIGHTS RESERVED. NO PORTION OF THIS PUBLICATION, WHETHER IN WHOLE OR IN PART CAN BE REPRODUCED WITHOUT THE EXPRESS WRITTEN CONSENT OF SPC TECHNOLOGY.

REVISIONS			DDC. NO. SPC-F004 * Effective: 12/21/98 * DCP No: 680					
DCP #	REV	DESCRIPTION	DRAWN	DATE	CHECKD	DATE	APPRVD	DATE
1979	A	RELEASED	JWM	2/14/00	JN	03/17/08	JN	03/17/08

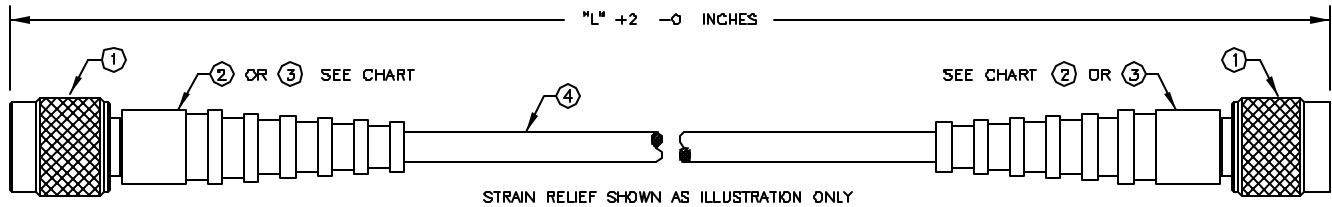

REW-5000-XX
 [L] LENGTH IN INCHES
 SPECIFIC PART NUMBER
 CABLE ASSEMBLY DESIGNATOR

SPC #	Cable Type	Length	Strain Relief
SPC20651	RG-55B/U	12	No
SPC20652	RG-55B/U	36	No
SPC20653	RG-55B/U	48	No
SPC20654	RG-55B/U	72	No
SPC20655	RG-58A/U	24	Yes
SPC20656	RG-58C/U	12	No
SPC20657	RG-62A/U	12	No
SPC20658	RG-62A/U	24	No
SPC20659	RG-62A/U	48	No
SPC20660	RG-62A/U	60	No



SPC-F004.DWG

DISCLAIMER:
 ALL STATEMENTS AND TECHNICAL INFORMATION CONTAINED HEREIN ARE BASED UPON INFORMATION AND/OR TESTS WE BELIEVE TO BE ACCURATE AND RELIABLE. SINCE CONDITIONS OF USE ARE BEYOND OUR CONTROL, THE USER SHALL DETERMINE THE SUITABILITY OF THE PRODUCT FOR THE INTENDED USE AND ASSUME ALL RISK AND LIABILITY WHATSOEVER IN CONNECTION THEREWITH.



SPC TECHNOLOGY

UNLESS OTHERWISE SPECIFIED, DIMENSIONS ARE FOR REFERENCE PURPOSES ONLY.	DRAWN BY:	DATE:	DRAWING TITLE:			
	Jeff McVicker	2/14/00	CABLE ASSEMBLY			
	CHECKED BY:	DATE:	TNC MALE CRIMP TO TNC MALE CRIMP		SIZE	DWG. NO.
	Jason Nash	03/17/08	A	TA-839	ELECTRONIC FILE	REV
APPROVED BY:	DATE:	SCALE: NTS		U.O.M.: INCHES [mm]		
Jason Nash	03/17/08			TA-839.DWG	A	
			SHEET: 1 OF 1			