


ALL RIGHTS RESERVED. NO PORTION OF THIS PUBLICATION, WHETHER IN WHOLE OR IN PART CAN BE REPRODUCED WITHOUT THE EXPRESS WRITTEN CONSENT OF SPC TECHNOLOGY.

REVISIONS			DDC. NO. SPC-F004 * Effective: 12/21/98 * DCP No: 680					
DCP #	REV	DESCRIPTION	DRAWN	DATE	CHECKD	DATE	APPRVD	DATE
1979	A	RELEASED	JN	10/07/08	JWM	10/07/08	JWM	10/07/08

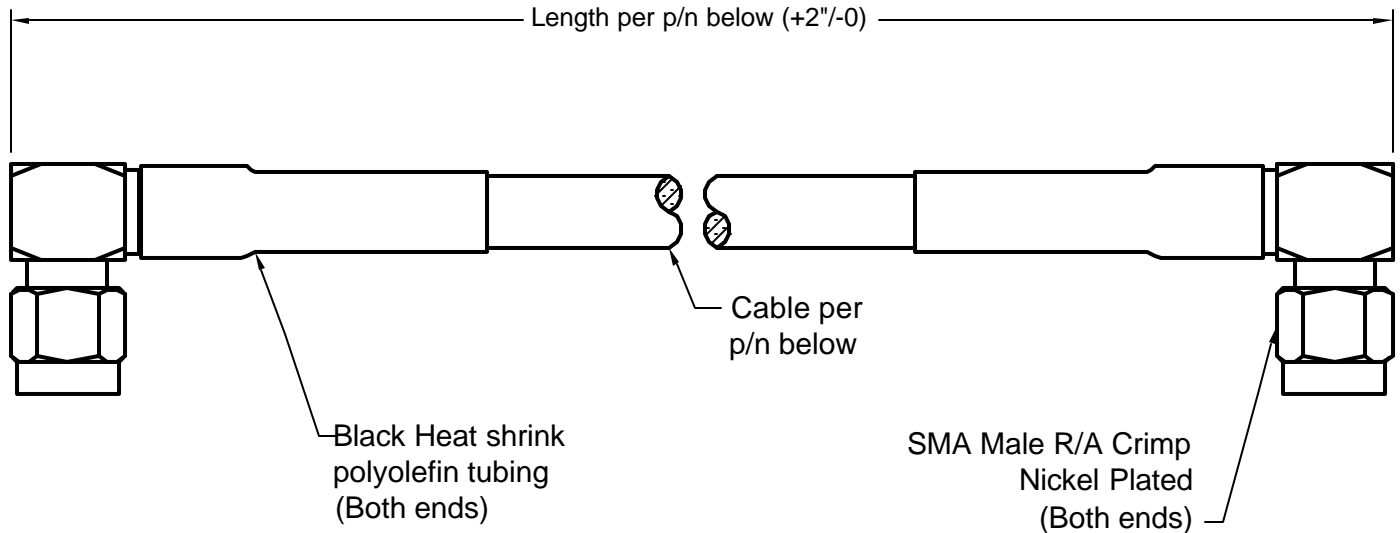

Type No.	Cable	Length <i>(Inches)</i>	Strain Relief
SPC20604	RG-55B/U	72	No
SPC20606	RG-58A/U	36	Yes
SPC20609	RG-58A/U	48	Yes
SPC20610	RG-58A/U	60	Yes

SPC-F004.DWG

**DISCLAIMER:**  
ALL STATEMENTS AND TECHNICAL INFORMATION CONTAINED HEREIN ARE BASED UPON INFORMATION AND/OR TESTS WE BELIEVE TO BE ACCURATE AND RELIABLE. SINCE CONDITIONS OF USE ARE BEYOND OUR CONTROL, THE USER SHALL DETERMINE THE SUITABILITY OF THE PRODUCT FOR THE INTENDED USE AND ASSUME ALL RISK AND LIABILITY WHATSOEVER IN CONNECTION THEREWITH.



**SPC TECHNOLOGY**

UNLESS OTHERWISE SPECIFIED, DIMENSIONS ARE FOR REFERENCE PURPOSES ONLY.

DRAWN BY:	DATE:
Jason Nash	10/07/08
CHECKED BY:	DATE:
JWM	10/07/08
APPROVED BY:	DATE:
JWM	10/07/08

DRAWING TITLE:  
Cable Ass'y - SMA Male R/A to SMA Male R/A

SIZE	DWG. NO.	ELECTRONIC FILE	REV
A	TA-949	TA-949.dwg	A

SCALE: NTS      U.O.M.: INCHES [mm]      SHEET: 1 OF 1